


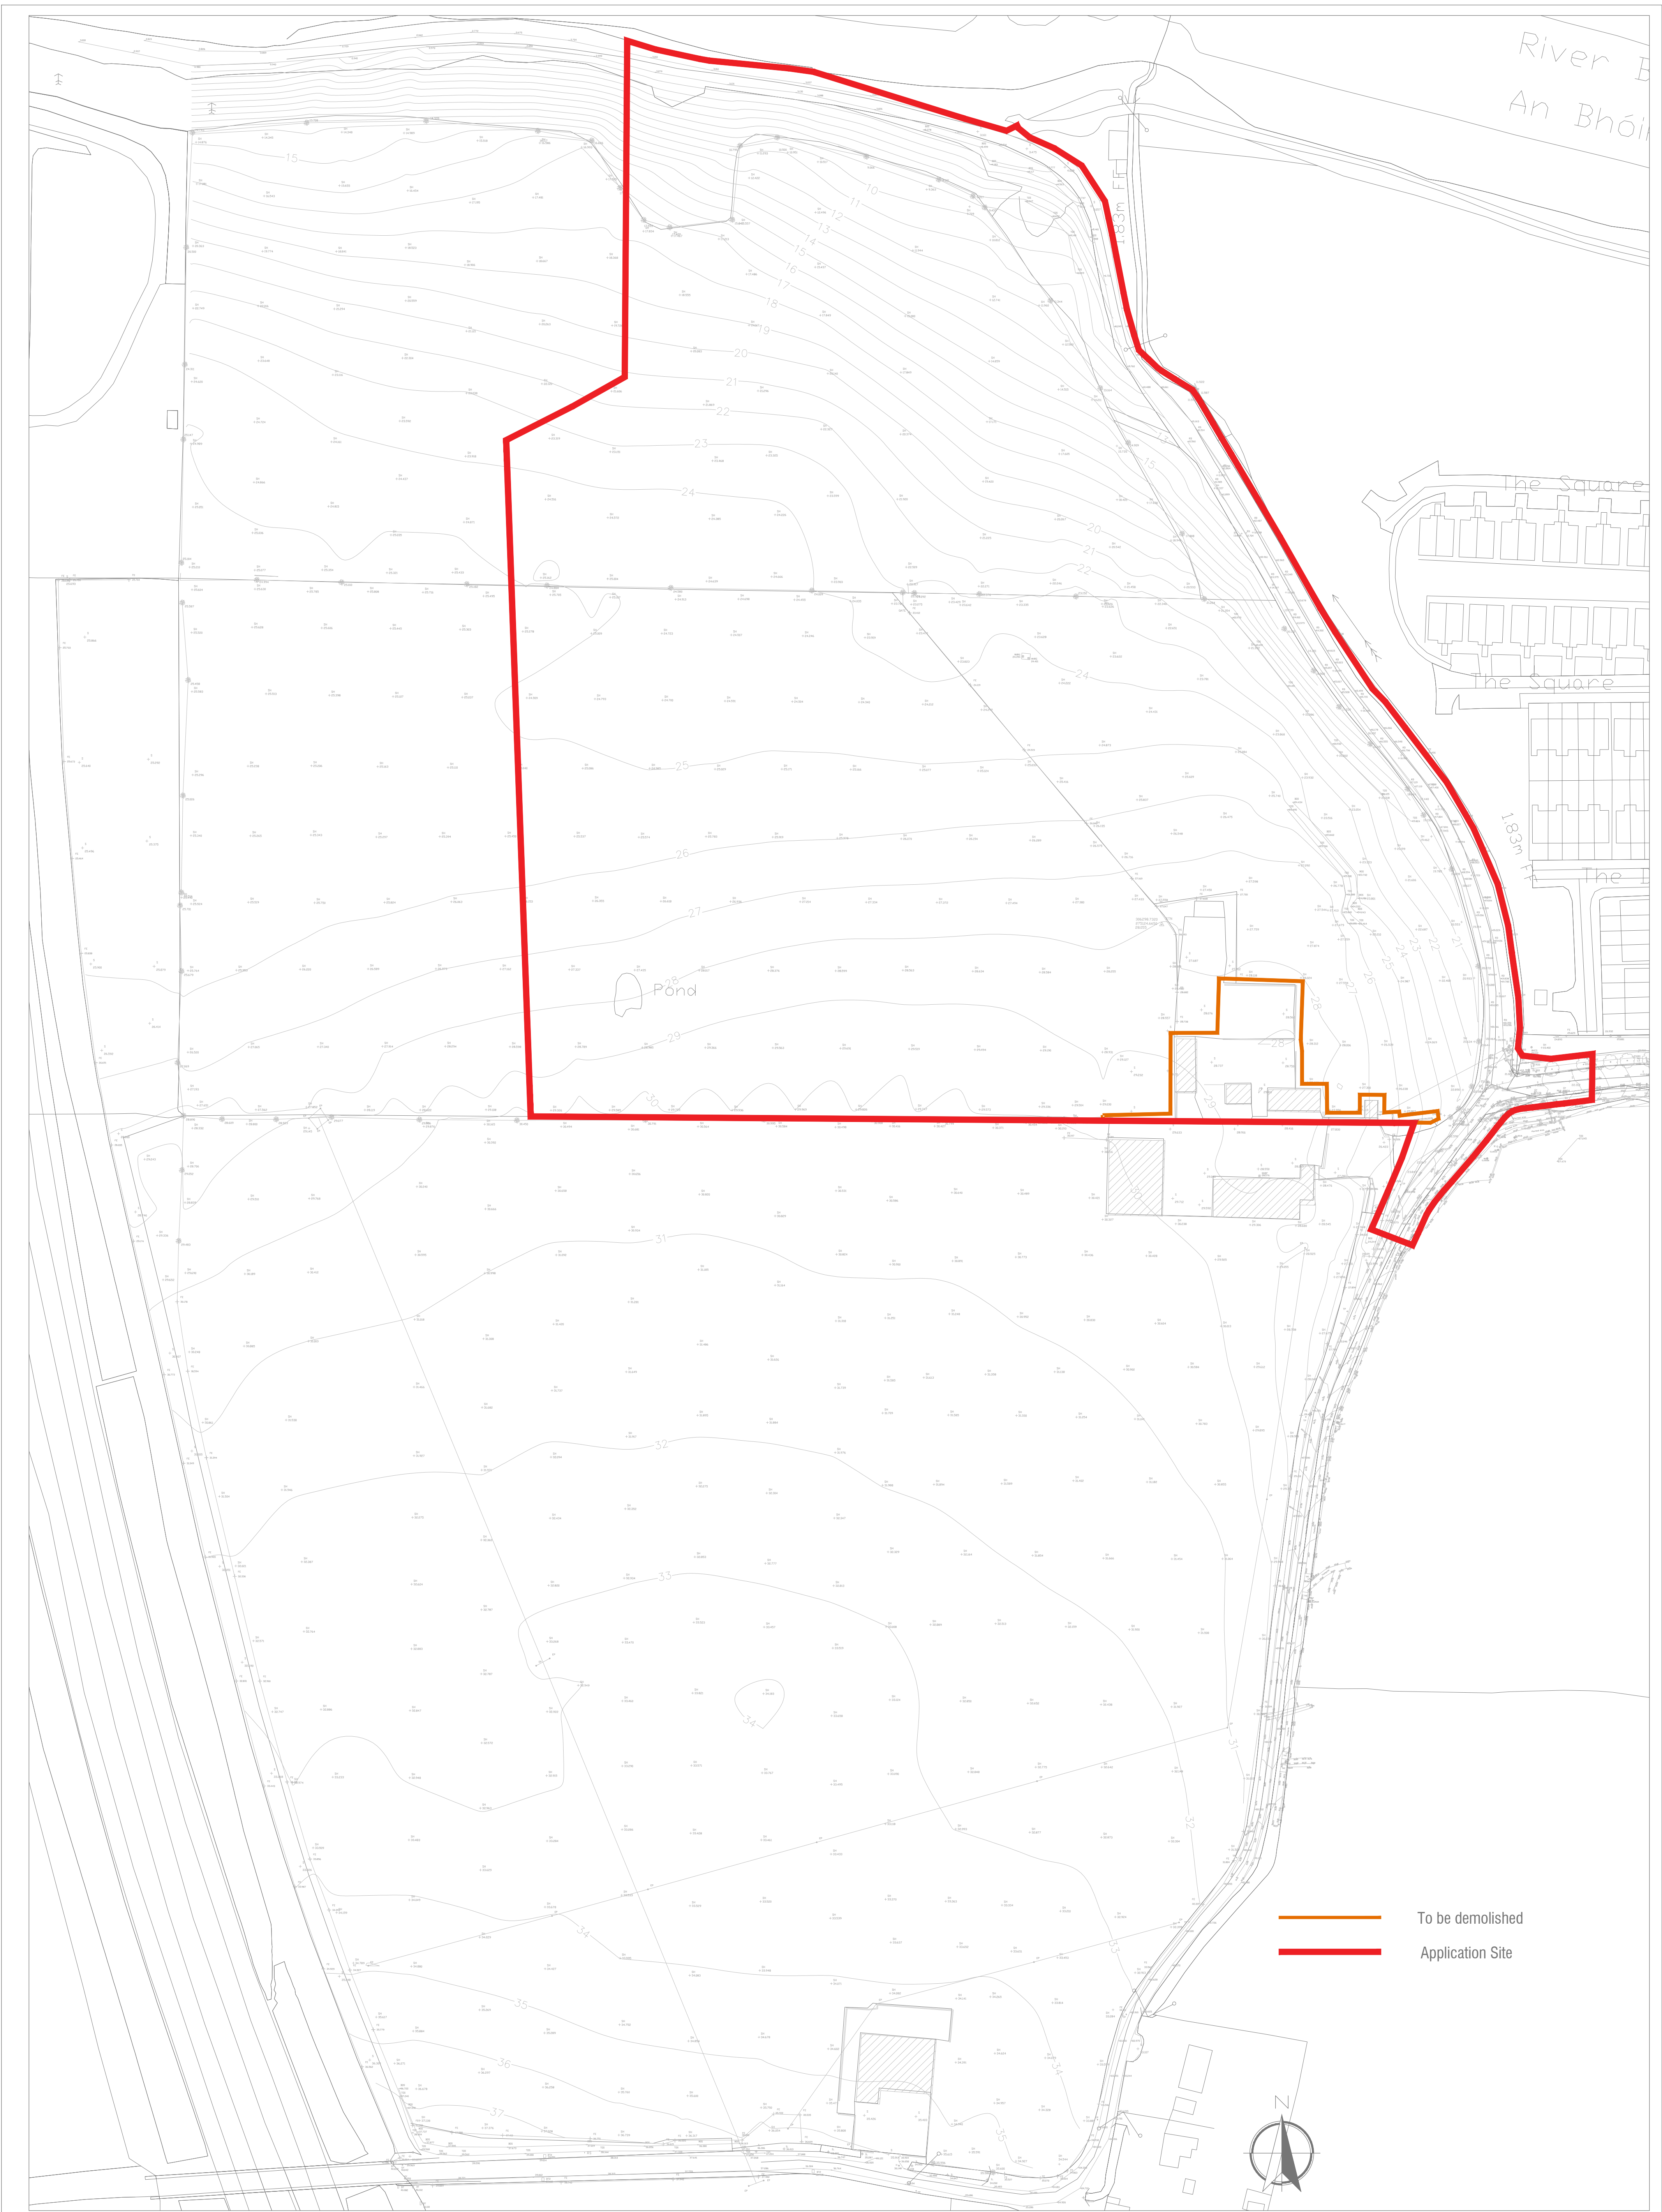

— To be demolished
— Application Site

- NOTES
1. Copyright Reserved.
 2. Work to figured dimensions only. Do not scale drawing.
 3. The contractor is responsible for checking all levels and dimension on site and shall refer all discrepancies to the Architect.
 4. Where appropriate, for details of R.C. structure, or mechanical and electrical details, see Engineers drawings.
 5. Proprietary items shall be fixed in strict accordance with manufacturers instructions.
 6. Sizes of proprietary items shall be checked with manufacturer.
 7. The contractor shall be responsible for the co-ordination of structure, finishes and services.

ISSUE STATUS	No.	Date	Revision	Initials	No.	Date	Revision	Initials
PROGRESS								
INFORMATION ONLY								
PLANNING APPLICATION								
TENDER								
FIRE CERT								
CONSTRUCTION								
DAC								
COMPLIANCE								

Project : LARGE-SCALE RESIDENTIAL DEVELOPMENT - BOYNE RIDGE
Client : Earlsfort Developments Ltd
Drawing Title: Existing Site Plan
Drawing No.: PL-SP-02
Date : 01/09/2025 Scale : 1:1000@A1 Drawn by: BW Checked by: JO'L Format: A1
Niall D. Brennan Associates, Grand Canal Wharf, Unit 5, S Dock Rd, Dublin 4
TEL (353 1) 478 90 09 FAX (353 1) 478 90 10 E-MAIL info@ndba.ie WEB www.ndba.ie

NDBA JOB NO.
23/004
REVISION NO.
0

ndba
architects
Niall D. Brennan Associates