



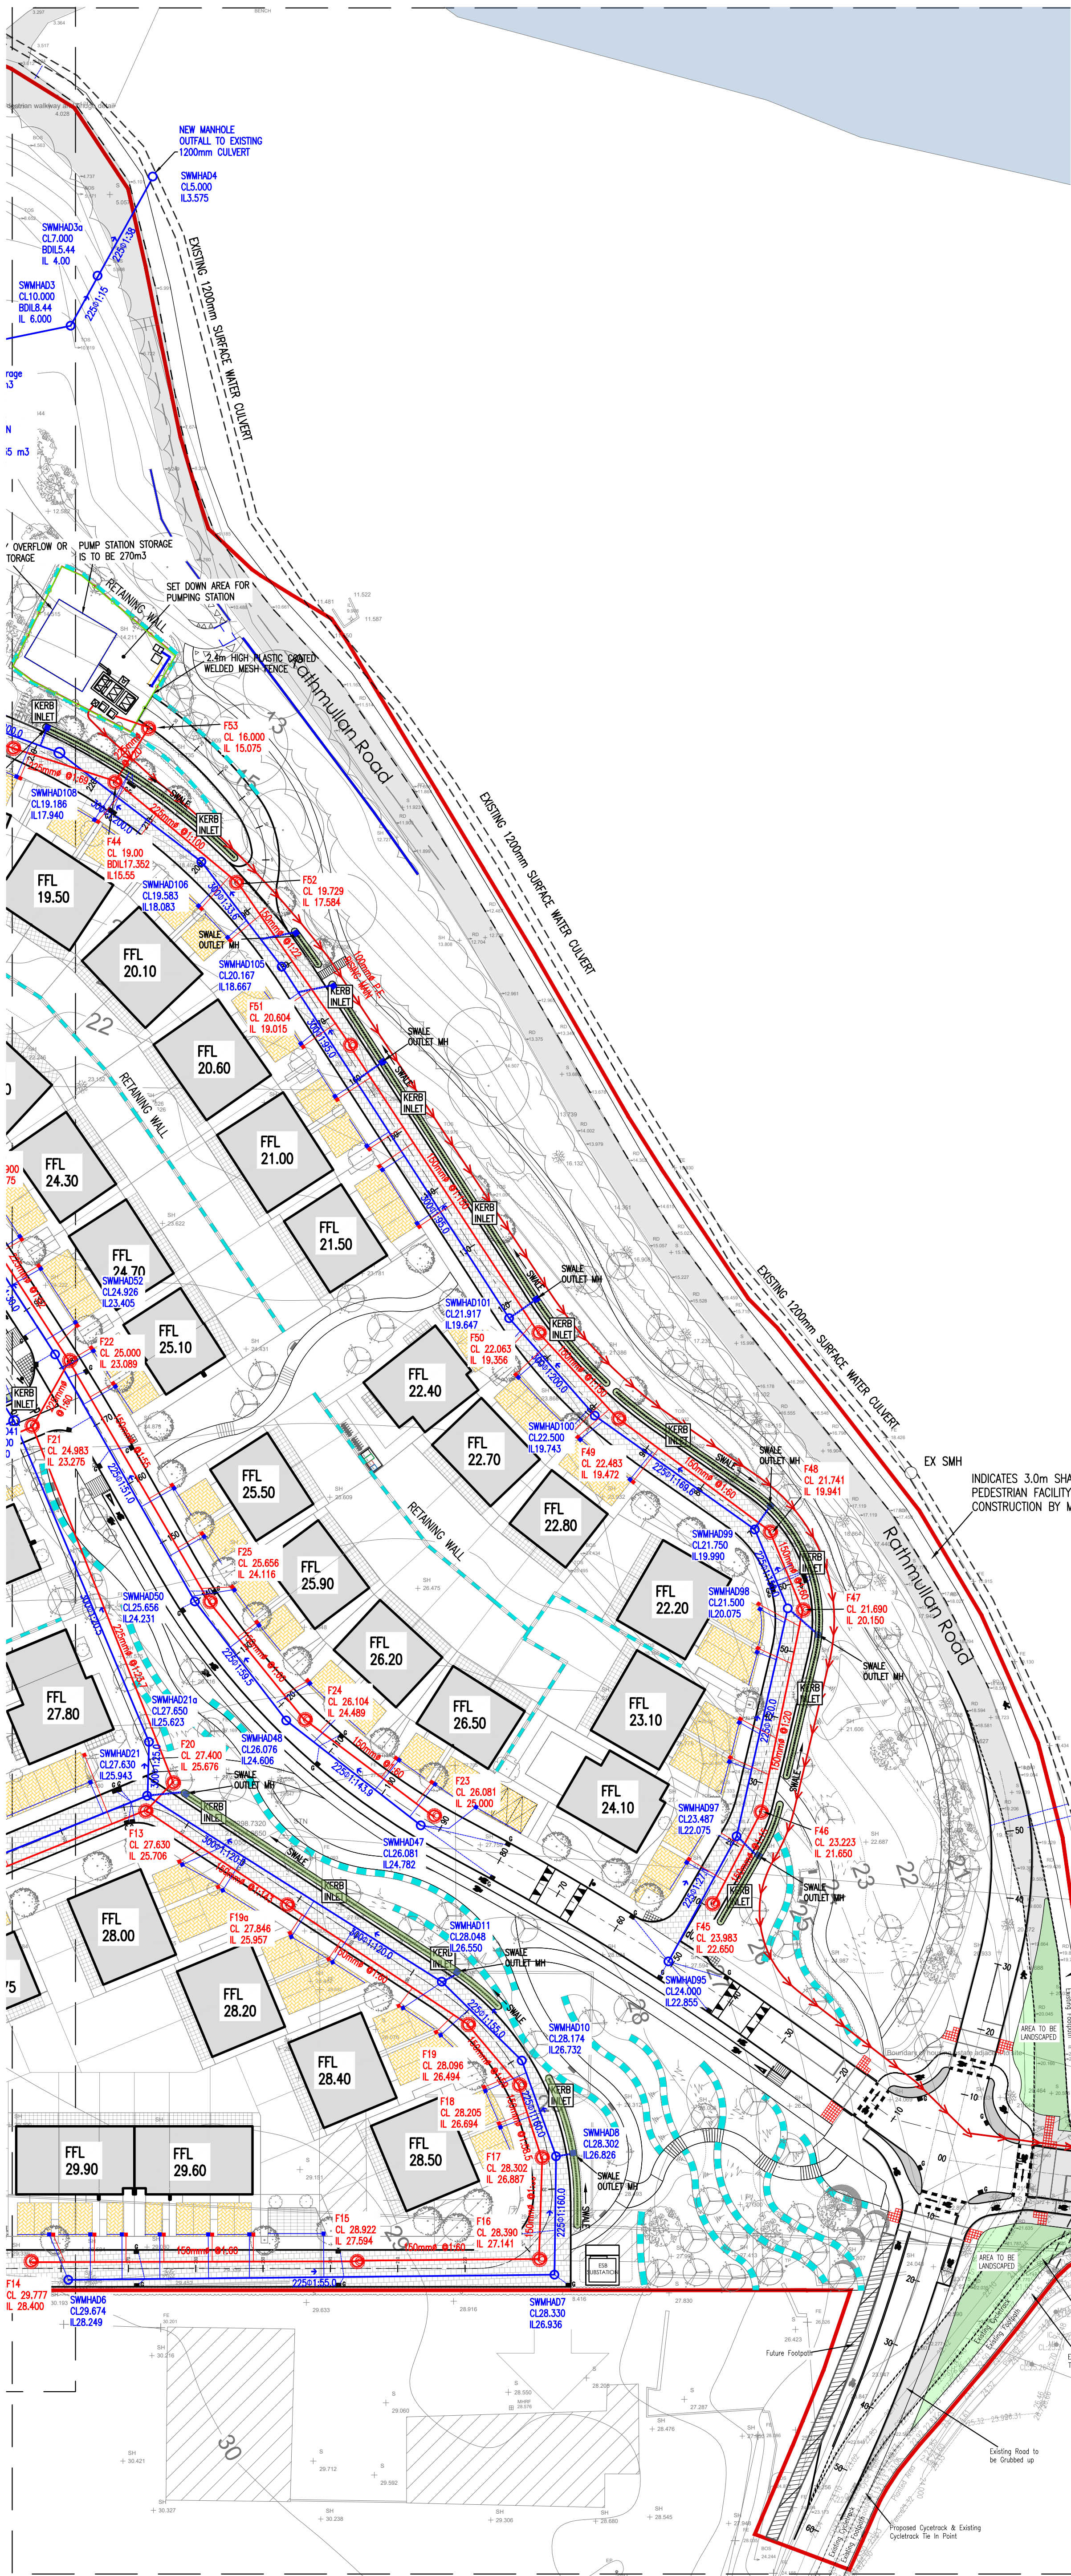

KEYPLAN

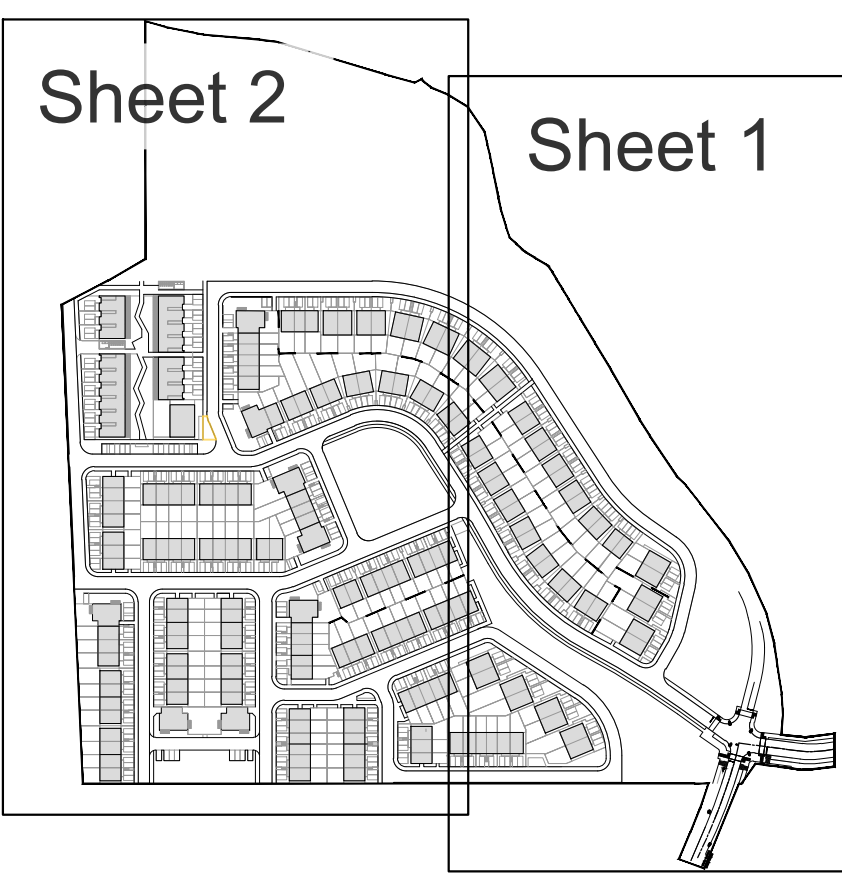

- NOTES:
- DO NOT SCALE. USE FIGURED DIMENSIONS ONLY.
 - THIS DRAWING IS TO BE READ IN CONJUNCTION WITH ALL OTHER RELEVANT ARCHITECTURAL AND ENGINEERING DRAWINGS.

LEGEND DRAINAGE

- PROPOSED SURFACE WATER SEWER & MANHOLE WITH REFERENCE & INVERT LEVEL
- PROPOSED uPVC FOUL WATER SEWER & MANHOLE WITH REFERENCE & INVERT LEVEL
- PROPOSED FOUL RISING MAIN
- EXISTING FOUL RISING MAIN
- EXISTING SURFACE WATER SEWER WITH PIPE SIZE, GRADE, MANHOLE REF. AND INVERT LEVEL
- EXISTING FOUL WATER SEWER & MANHOLE WITH REFERENCE & INVERT LEVEL
- PROPOSED ROAD GULLY & CONNECTION
- PROPOSED GRASS SWALE WITH 100mm PERFORATED PIPE
- PROPOSED KERB INLET LOCATION
- PROPOSED PERMEABLE PAVING
- PROPOSED STORM WATER HOUSE DRAIN AND ACCESS CHAMBER
- PROPOSED FOUL WATER HOUSE DRAIN AND ACCESS CHAMBER

PROPOSED DRAINAGE LAYOUT - SHEET 1 OF 2

SCALE 1:500 @A1

A 13/06/25		LAYOUT UPDATES			LS	BG		
Rev	Date	Description			By	CHK		
Amendments								
Project								
PROPOSED RESIDENTIAL DEVELOPMENT								
RATHMULLAN								
DROGHEDA								
Title								
PROPOSED DRAINAGE LAYOUT								
SHEET 1 OF 2								
Client								
EARLSFORT DEVELOPMENTS DROGHEDA LIMITED								
 waterman moylan								
BLOCK S, EASTPOINT BUSINESS PARK, ALFIE BYRNE ROAD, DUBLIN D03 H3F4 IRELAND. Tel: (01) 664 8900 Email: info@waterman-moylan.ie www.waterman-moylan.ie								
Status								
LRD PLANNING - STAGE 3								
Designed By		LS	Approved	JG	Waterman Ref	18-014		
Drawn By		SH	Date	MAY.2025		Scales @ A1 1:500 @A1		
Project - Originator - Volume - Level - Type - Role - Number						Revision		
RAT - WMX - PH2 - 00 - DR - C - P451						A		