


KEYPLAN

Sheet 2

Sheet 1

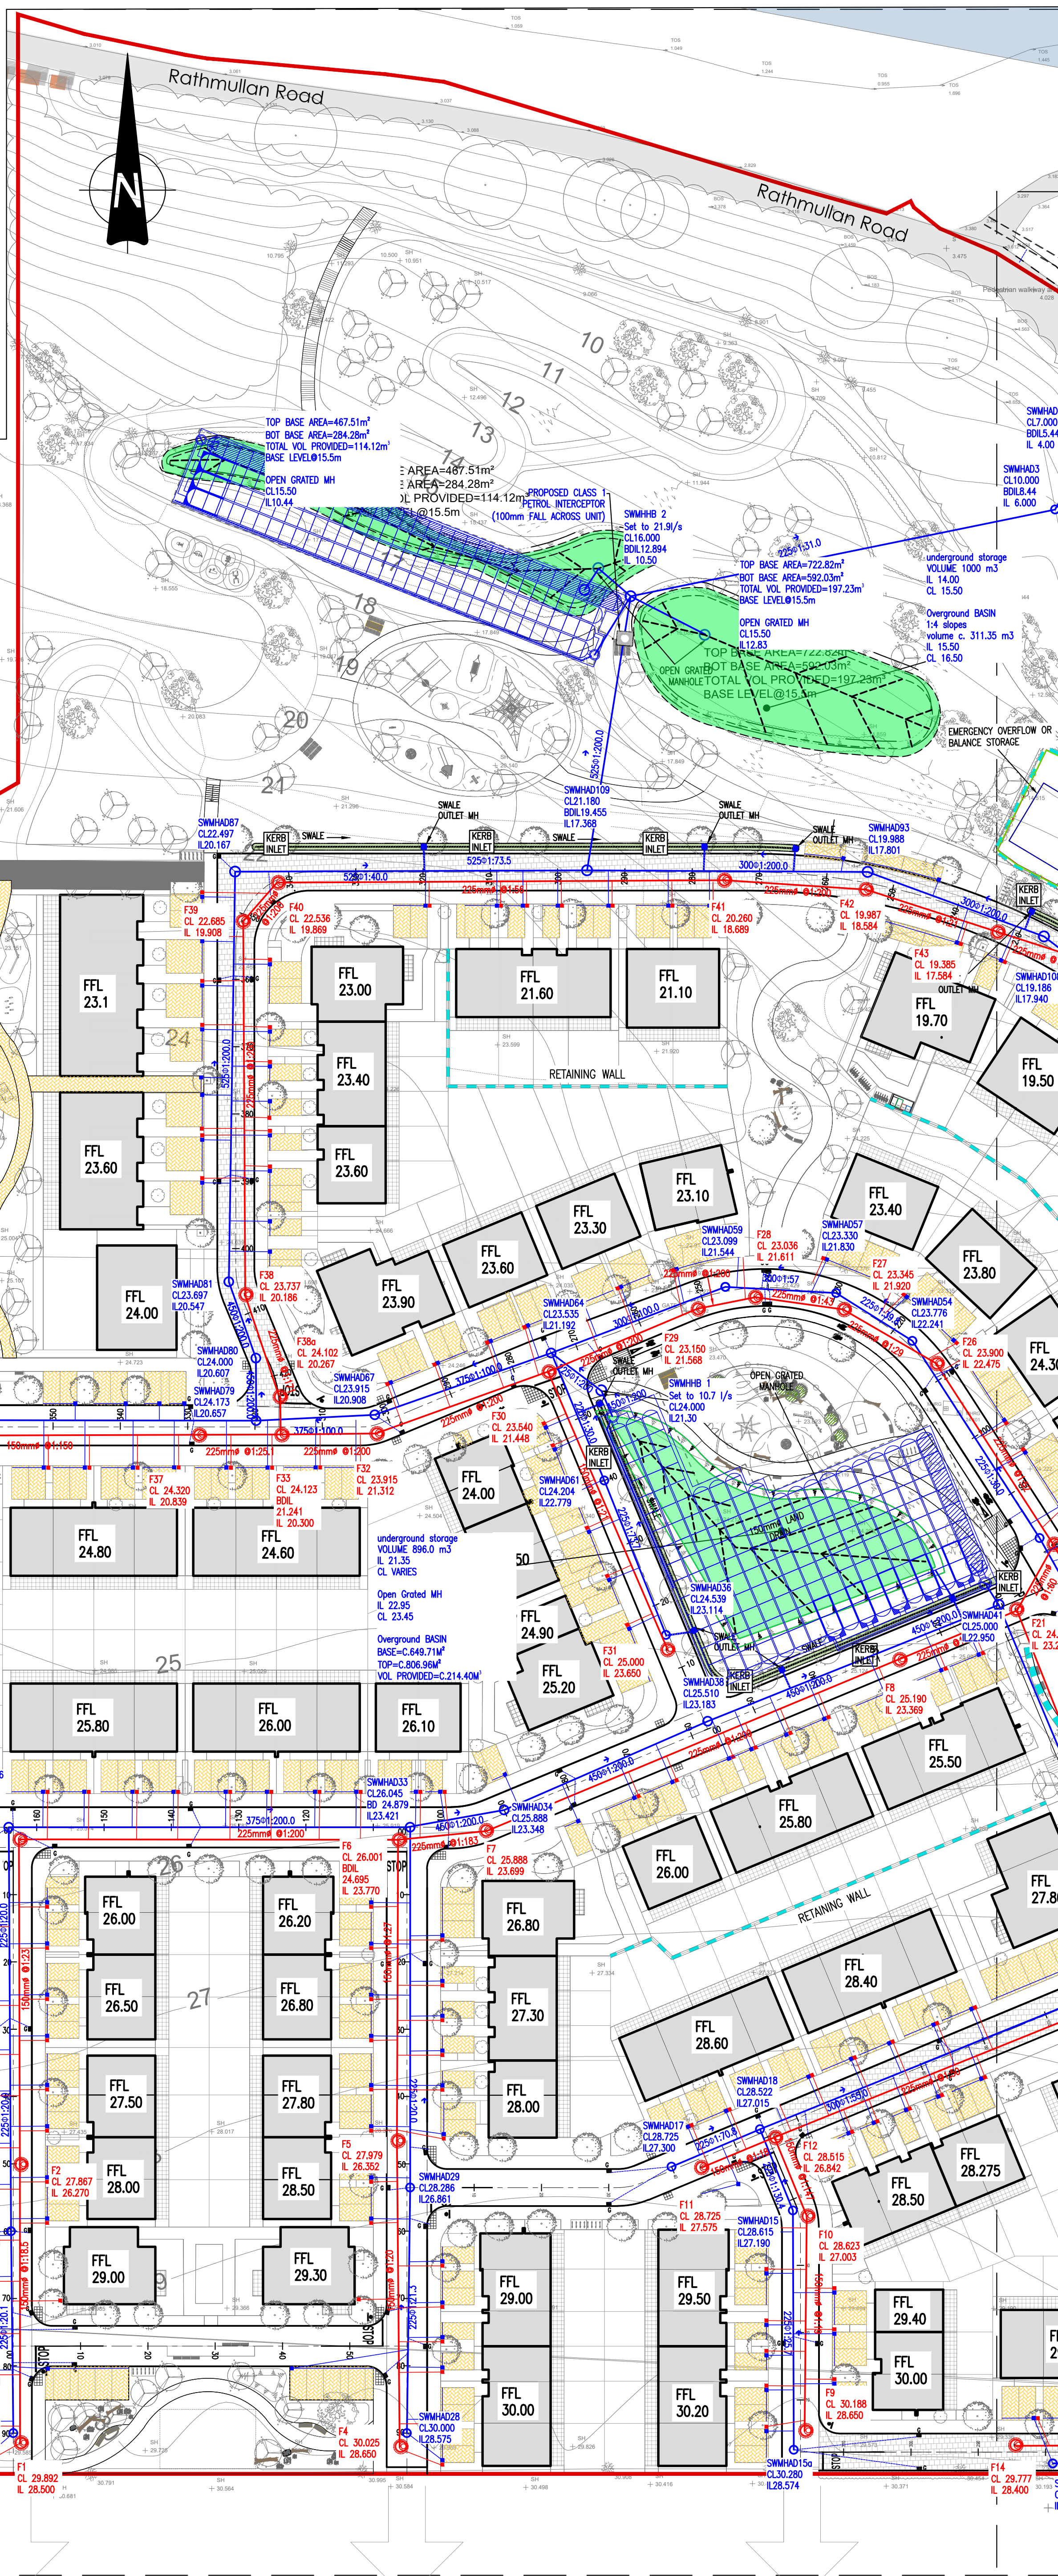

NOTES:

- DO NOT SCALE. USE FIGURED DIMENSIONS ONLY.
- THIS DRAWING IS TO BE READ IN CONJUNCTION WITH ALL OTHER RELEVANT ARCHITECTURAL AND ENGINEERING DRAWINGS.

LEGEND DRAINAGE

- PROPOSED SURFACE WATER SEWER & MANHOLE WITH REFERENCE & INVERT LEVEL
- PROPOSED uPVC FOUL WATER SEWER & MANHOLE WITH REFERENCE & INVERT LEVEL
- PROPOSED FOUL RISING MAIN
- EXISTING FOUL RISING MAIN
- EXISTING SURFACE WATER SEWER WITH PIPE SIZE, GRADE, MANHOLE REF. AND INVERT LEVEL
- EXISTING FOUL WATER SEWER & MANHOLE WITH REFERENCE & INVERT LEVEL
- PROPOSED ROAD GULLY & CONNECTION
- PROPOSED GRASS SWALE WITH 100mm PERFORATED PIPE
- PROPOSED KERB INLET LOCATION
- PROPOSED PERMEABLE PAVING
- PROPOSED STORM WATER HOUSE DRAIN AND ACCESS CHAMBER
- PROPOSED FOUL WATER HOUSE DRAIN AND ACCESS CHAMBER

PROPOSED DRAINAGE LAYOUT - SHEET 2 OF 2

SCALE 1:500 @A1

Rev	Date	Description	By	CHK
Amendments				

Project: PROPOSED RESIDENTIAL DEVELOPMENT RATHMULLAN DROGHEDA

Title: PROPOSED DRAINAGE LAYOUT SHEET 2 OF 2

Client: EARLSFORT DEVELOPMENTS DROGHEDA LIMITED

waterman moylan

BLOCK 5, EASTPOINT BUSINESS PARK, ALFIE BYRNE ROAD, DUBLIN D03 H3F4 IRELAND. Tel: (01) 664 8900
Email: info@waterman-moylan.ie www.waterman-moylan.ie

Status: LRD PLANNING - STAGE 3

Designed By	Approved	Waterman Ref
LS	JG	18-014

Drawn By	Date	Scale	Revision
SH	JAN.2025	@A1	1:500 @A1

Project - Originator - Volume - Level - Type - Role - Number

RAT - WMX - PH2 - 00 - DR - C - P452

A